

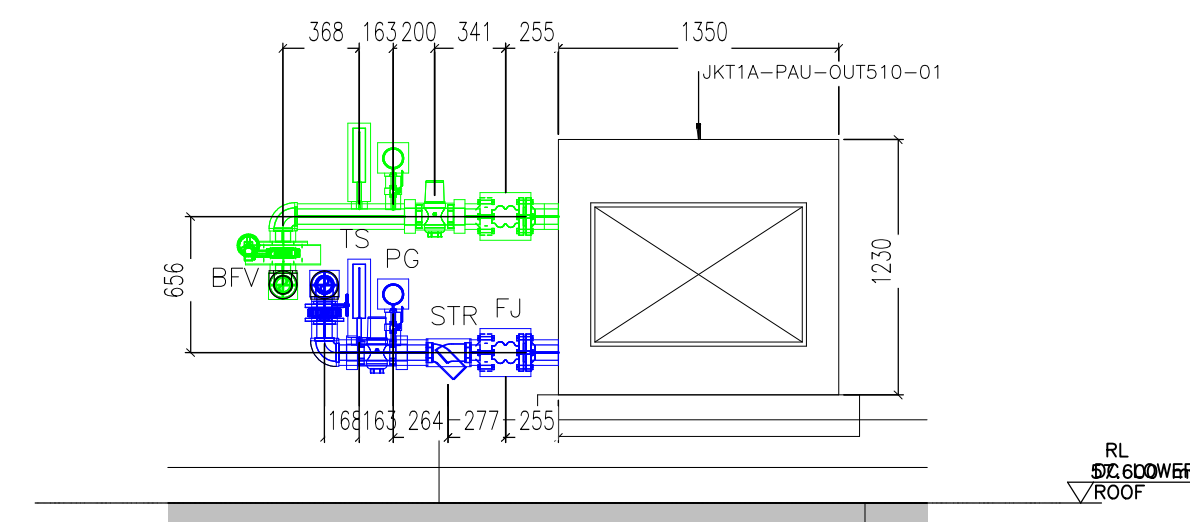
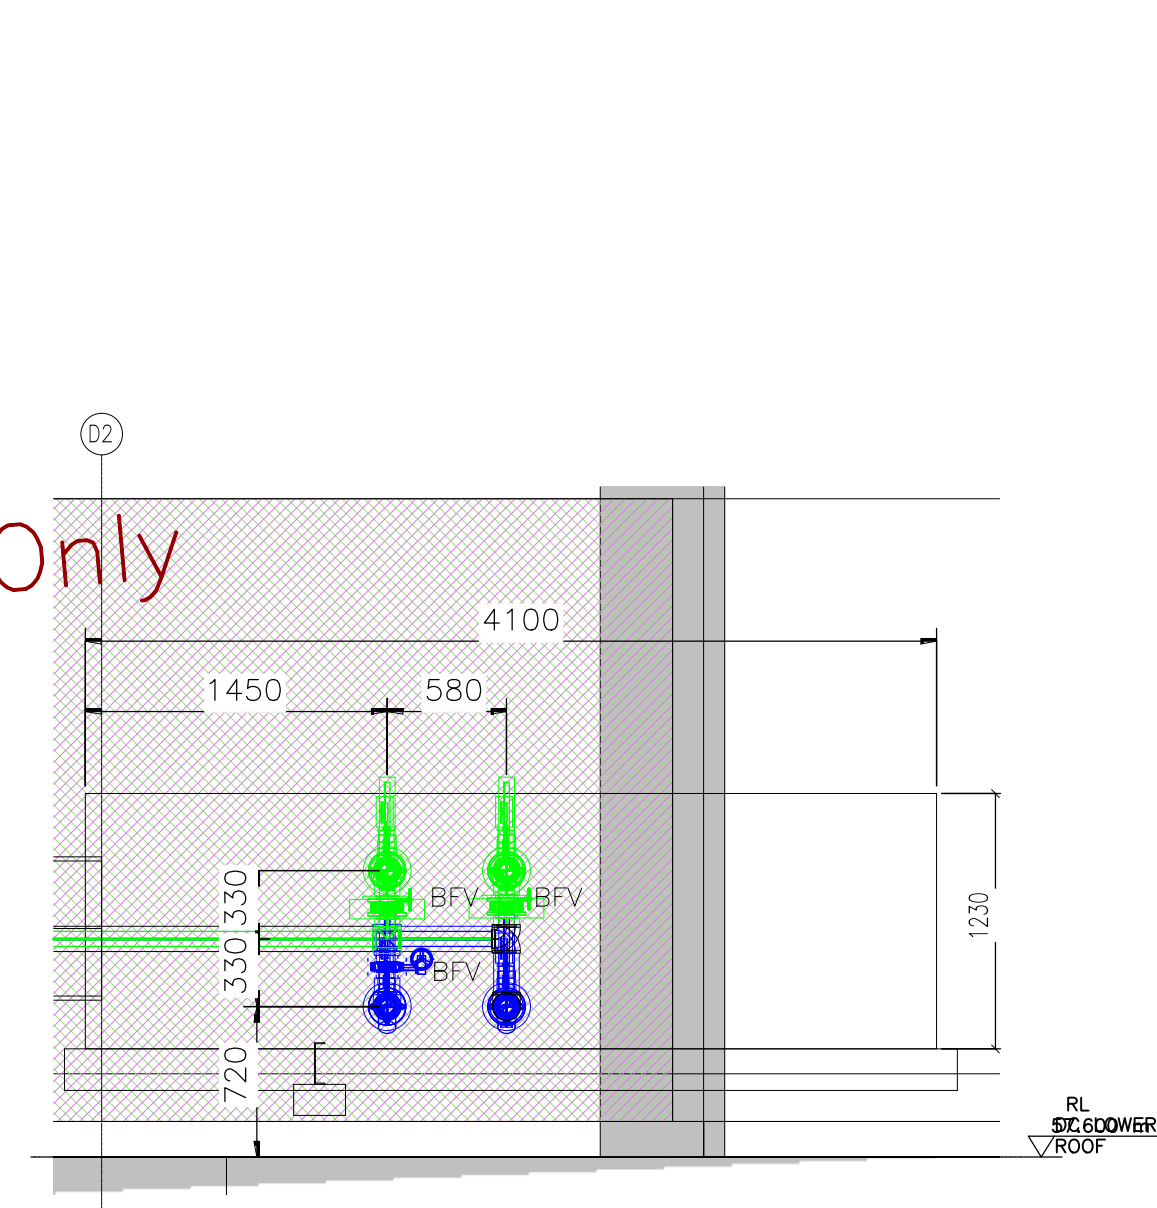
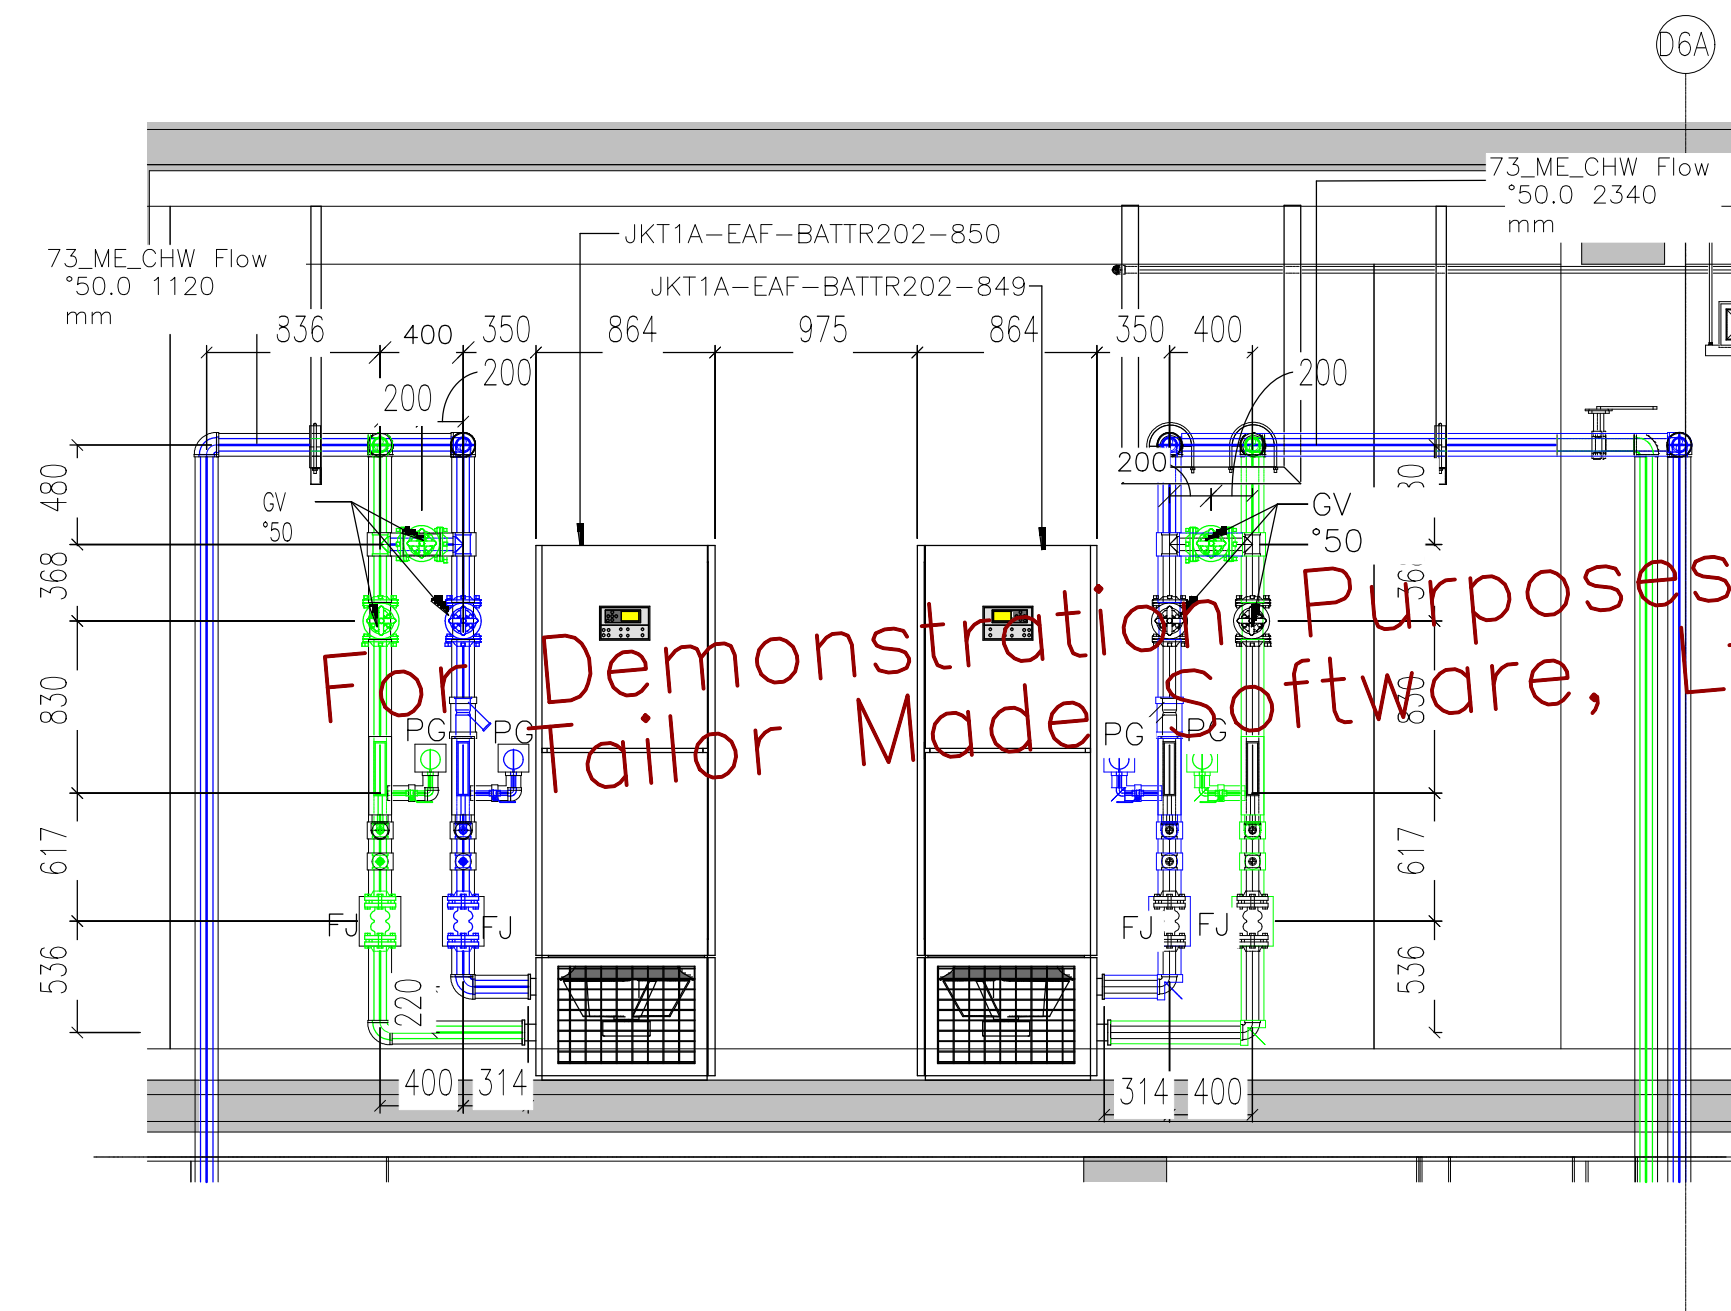
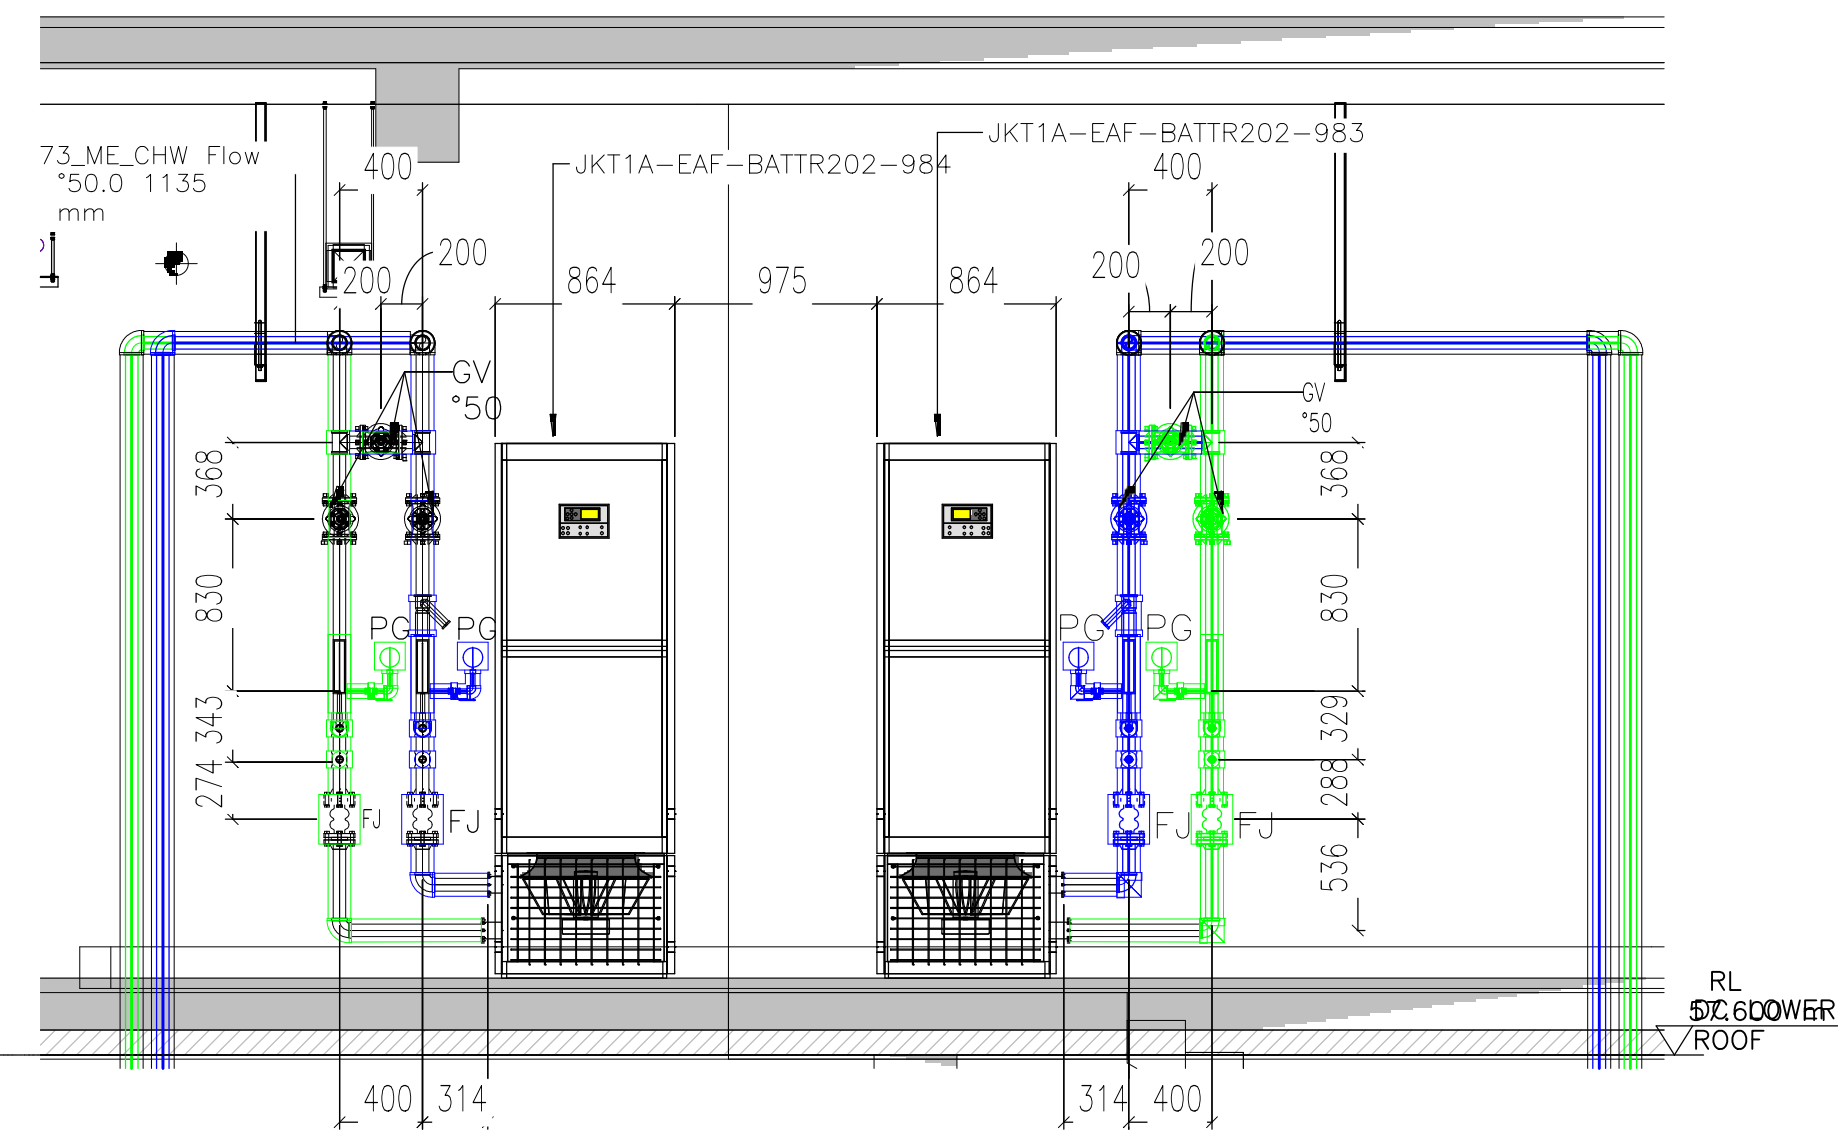
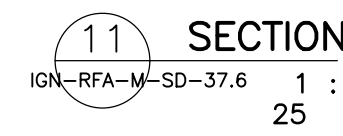
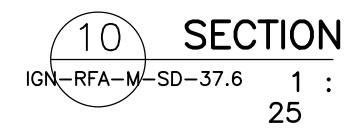


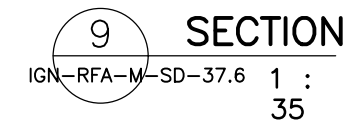

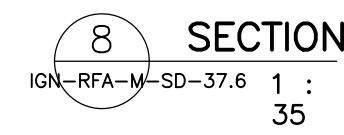

|                                   |                   |      |
|-----------------------------------|-------------------|------|
| DRAWING NO.                       | IGN-RFA-M-SD-37.6 |      |
| REFERENCE                         |                   |      |
| DRAWING TITLE :                   |                   |      |
| MECHANICAL SERVICES -             |                   |      |
| PIPING PLANS -BLOCK A             |                   |      |
| ROOF FLOOR PLAN - DAY-1 SECTION 3 |                   |      |
| SCALE                             | PAGE<br>OF        | REV. |
| NTS                               | 7/8               | 2    |