
 



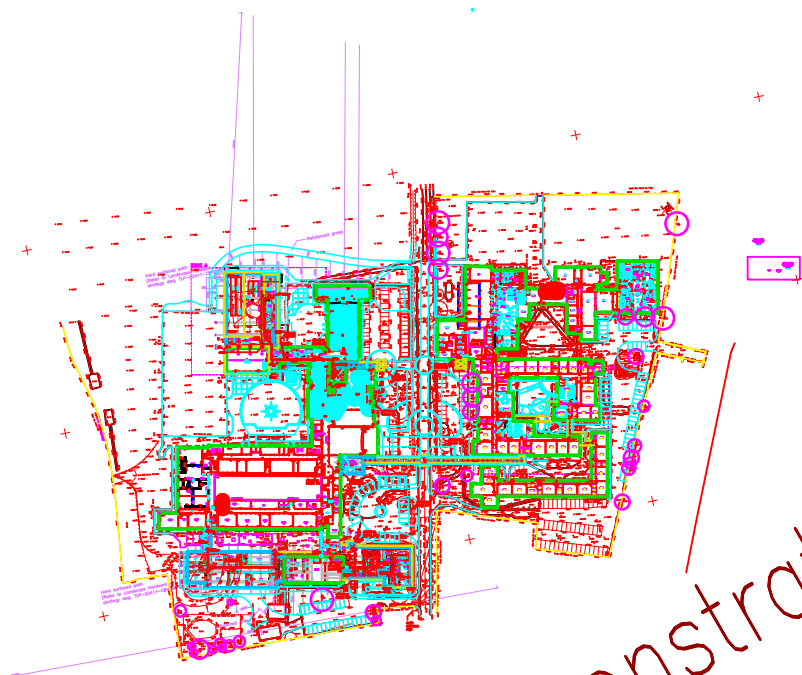

For Demonstration Purposes Only
Tailor Made Software, Ltd




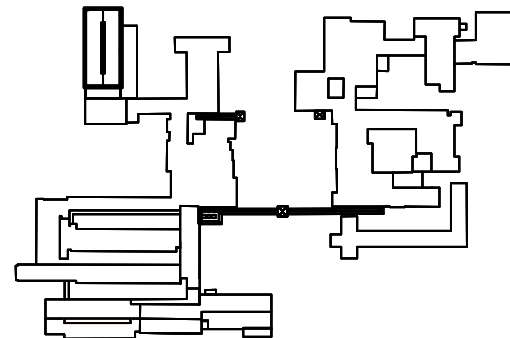

100mm on original sheet

revisions				
no.	description	date	initial	check
A	FIRST ISSUE	01.09.04	RLA	

KEY PLAN

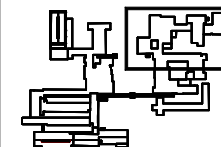

only
note

INFORMATION

DO NOT SCALE FROM THIS DRAWING
DRAWING SUBJECT TO COPYRIGHT ACT

ACP

Architects Co-Partnership
Northaw House, Coopers Lane, Northaw, Hertfordshire EN6 4PS
Telephone 01707 651141 Fax 01707 652800
Email: info@acpartnerships.co.uk

client

WATES CONSTRUCTION

project

COLBAYNS HIGH SCHOOL


drawing

GROUND FLOOR PLAN
FIRE STRATEGY
SHEET 3 OF 4

scale	date drawn	drawn by
1:200	25/08/04	PR

1 check date	checked by	2 check date	checked by
01.09.04	AL	01.09.04	RLA

drawing no.	version
3525(CoI) AL(0)3	72A

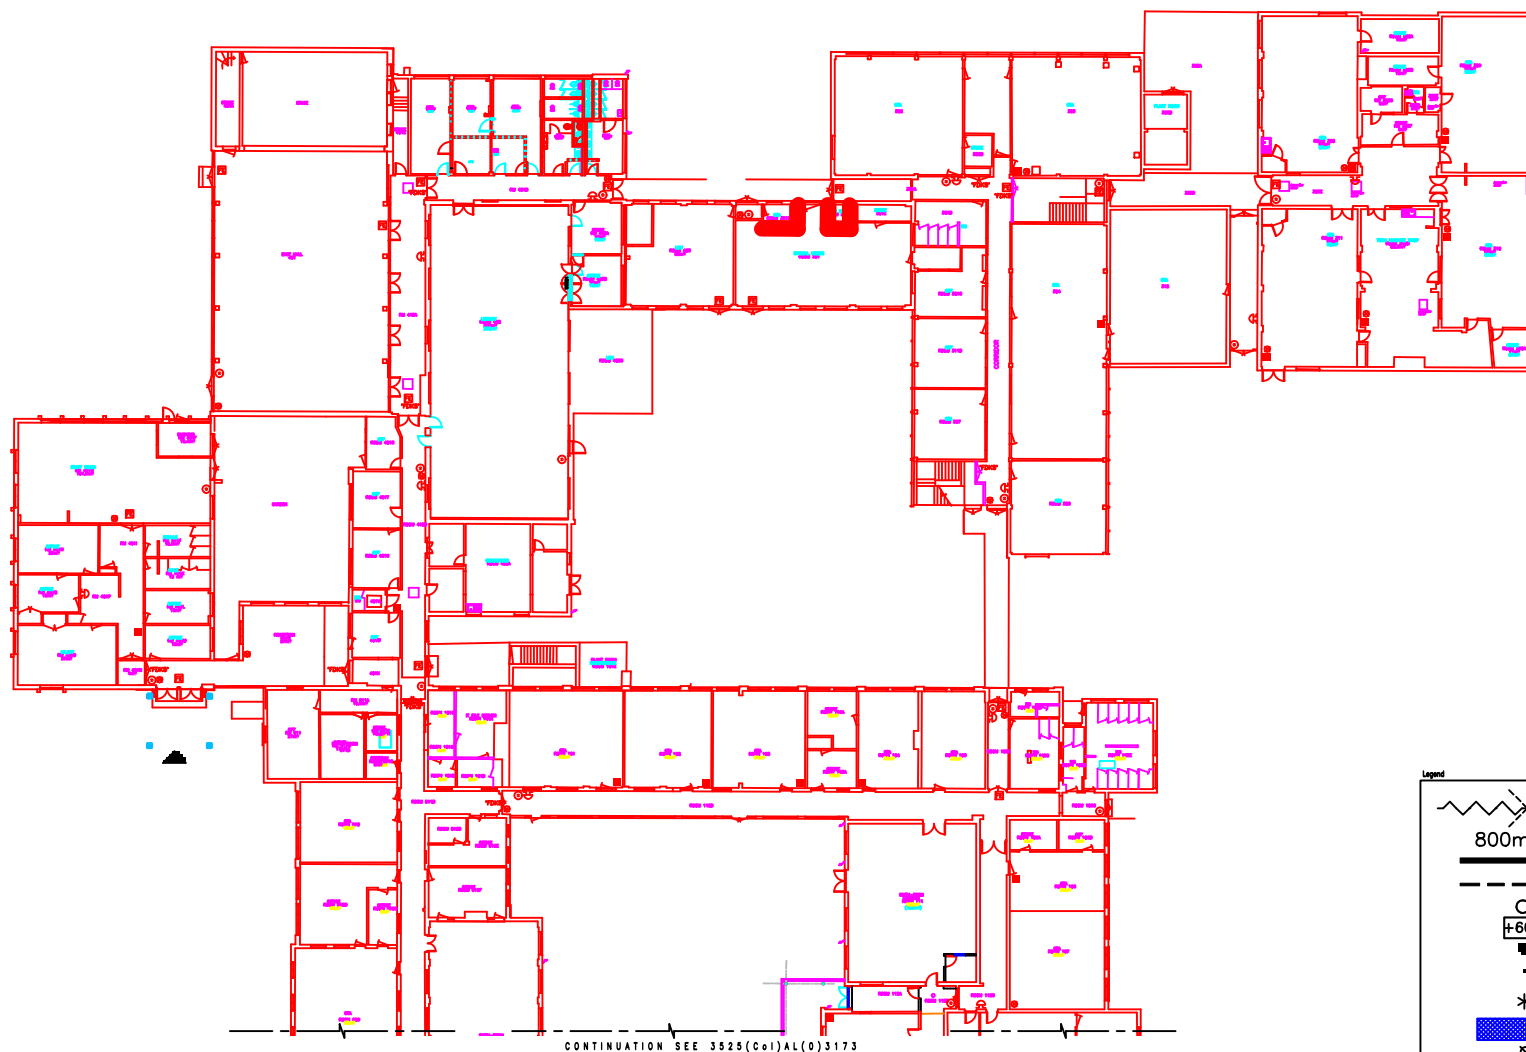

Legend	
	Escape route
	800m2 compartment area
	1hr compartment wall
	1/2hr compartment wall
	High risk area
	+60 Rooms with 60 people or over
	1hr fire door
	1/2hr fire door
	Door with electromagnetic hold-open device
	1hr corridor over 20m in length
	Foil/water extinguisher
	CO2 extinguisher
	Call point
	Sounder
	FE Fire escape sign
	Fire blanket
	FDKS 'Fire door keep shut' plaque